


Proposed Addition

Existing YMCA Building  
 FF = 97.16'  
 LL = 85.15'



"W1-3" BEACON TRAVERSE

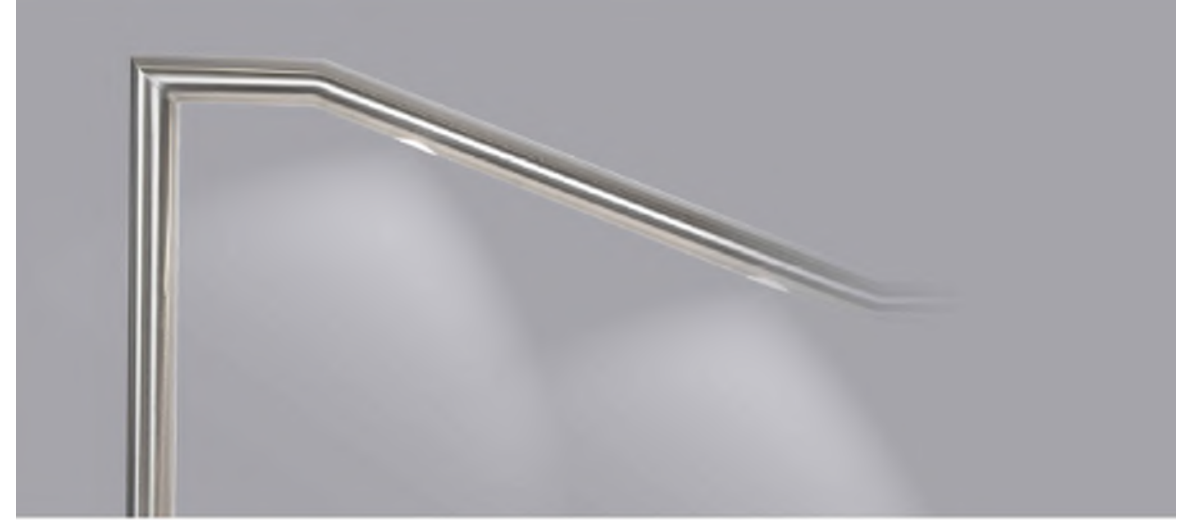

"ER-AS" V-RAIL SPOT ILLUMINATED HANDRAIL SYSTEM




"W2-FW" TARGETTI ZEDGE-MINI



"B1-3HS" KIN LIGHTING PAVILION ROUND

LIGHTING FIXTURE SCHEDULE									
TYPE	DESCRIPTION	MANUFACTURER	LAMPS	VOLT	WATTS	REMARKS	EQUIVALENT		
					FIXT.		BY		
W1-3	BEACON TRAVERSE TYPE 3 DISTRIBUTION MOUNTING HEIGHT 84" 96"	TRV-D32L-45-AM-3-UNV-PCD-DBT	LED 1400K 1245 LUMENS	MVOLT	45W	SHALL BE DARK SKY COMPLIANT. VERIFY MOUNTING LOCATION WITH ARCHITECTURAL DRAWINGS.			
ER-AS	LEVITON INTENSE LIGHTING V-RAIL SPOT ILLUMINATED HANDRAIL SYSTEM ASYMMETRIC 48" SPACING. EMBEDDED MOUNTING HEIGHT 36"	V15R-P48-S1454-E36M130AS-RD10UNV	LED 2700K 148 LUMENS	MVOLT	1.9W PER ENGINE	SHALL BE DARK SKY COMPLIANT. VERIFY LAYOUT AND FINISH OF HANDRAIL WITH ARCHITECTURAL DRAWINGS. PROVIDE WITH REMOTE POWER SUPPLY AND EMERGENCY INVERTER			
W2-FW	TARGETTI ZEDGE MINI FLOOR WASHER SPACED AT APPROX. 48" MOUNTING HEIGHT 12"	ZESRPF-WFEL13024MG POWER SUPPLY: 2MLES1242UD STAINLESS STEEL BACK BOX	LED 2700K 87 LUMENS	MVOLT	4W	SHALL BE DARK SKY COMPLIANT. VERIFY FINISH WITH ARCHITECT. PROVIDE WITH REMOTE POWER SUPPLY.			
B1-3HS	KIN LIGHTING PAVILION ROUND TYPE 3 DISTRIBUTION WITH HOUSE SIDE SHIELD 22" BODY	PAVR-F1-NU-3HS-1210-AMB-42A-D	LED AMBER 684 LUMENS	MVOLT	14W	SHALL BE DARK SKY COMPLIANT AND WILD LIFE FRIENDLY. VERIFY FINISH WITH ARCHITECT			
EX-B	EXISTING TO REMAIN/RELOCATED TEKA FULL CUTOFF SITE BOLLARD	PPL-2546	16 39WMMH	277	45W	SEE ELECTRICAL SITE PLAN.			

NOTES:  
 1. PROVIDE DRIVER DISCONNECT IN ALL FIXTURES IN ACCORDANCE WITH NEC.

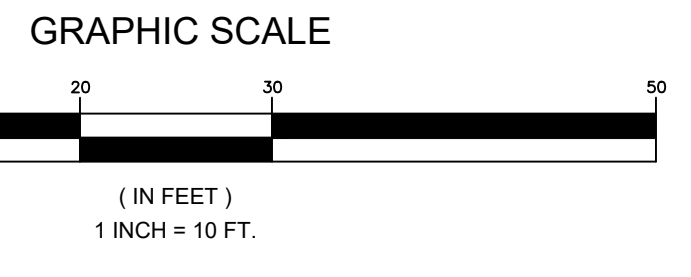

**Project**  
 Field House Addition  
 111R Edgartown Vineyard Haven Rd  
 Vineyard Haven MA 02568

**Client**  

 YMCA of Martha's Vineyard

**Team**  
**Architect**  
 Fennick McCredie Architecture  
 70 Franklin Street  
 Boston MA 02110  
 t. 617.353.7900

**Envelope Engineer**  
 Simpson Gumpertz & Heger  
 800 Boylston St Ste 2320  
 Boston MA 02119  
 t. 617.963.4500

**Geotechnical Engineer**  
 Charles Gross  
 23 Liberty Circle  
 Hanson MA 02341  
 t. 617.909.5180

**Landscape Architect**  
 Landscape  
 6 A Street  
 Edgartown MA 02539  
 t. 508.696.6812

**Civil Engineer**  
 Rist-Frost-Shumway  
 71 Water Street  
 Laconia NH 03246  
 t. 603.524.4647

**Structural Engineer**  
 LA Fuess Partners  
 211 Congress St Ste 810  
 Boston MA 02110  
 t. 617.342.7424

**MEFP Engineer**  
 BVH Integrated Services  
 One Gateway Ctr Ste 701  
 Newton MA 02458  
 t. 617.658.9008

Design Development

Key Plan:

Stamp:

NOT FOR CONSTRUCTION

No.	Date	Revision

Job No.: 10074  
 Drawn By: JBI  
 Checked By: AMS  
 Date: 08/09/2023  
 Scale: AS NOTED

Drawing Title:  
 SITE PHOTOMETRIC PLAN

Drawing No.:  
 E-002